

CLIENT INFORMATION

SEAL

REVISIONS

NO.	DATE	DESCRIPTION
A	9/17/08	BID WALK THRU SET
B	3/10/09	REVISED PER UTILITY COMMENTS

ST. JOACHIM & ANNE
2720 SURF AVENUE
BROOKLYN, NY 11224

ENERGY CONSERVATION

PROJECT NAME

SCALE PHASE

ONE-LINE DIAGRAM - ELECTRICAL


DRAWING TITLE

08003-e301.dwg	GJC
DRAWING FILE	DRAWN BY
08003	KAH
PROJECT NO.	CHECKED BY
4/10/2008	WHC
DATE	PROJ. MANAGER

© 2008 INTEGRATED ENERGY CONCEPTS ENGINEERING, P.C.

E3.01

DRAWING NO.

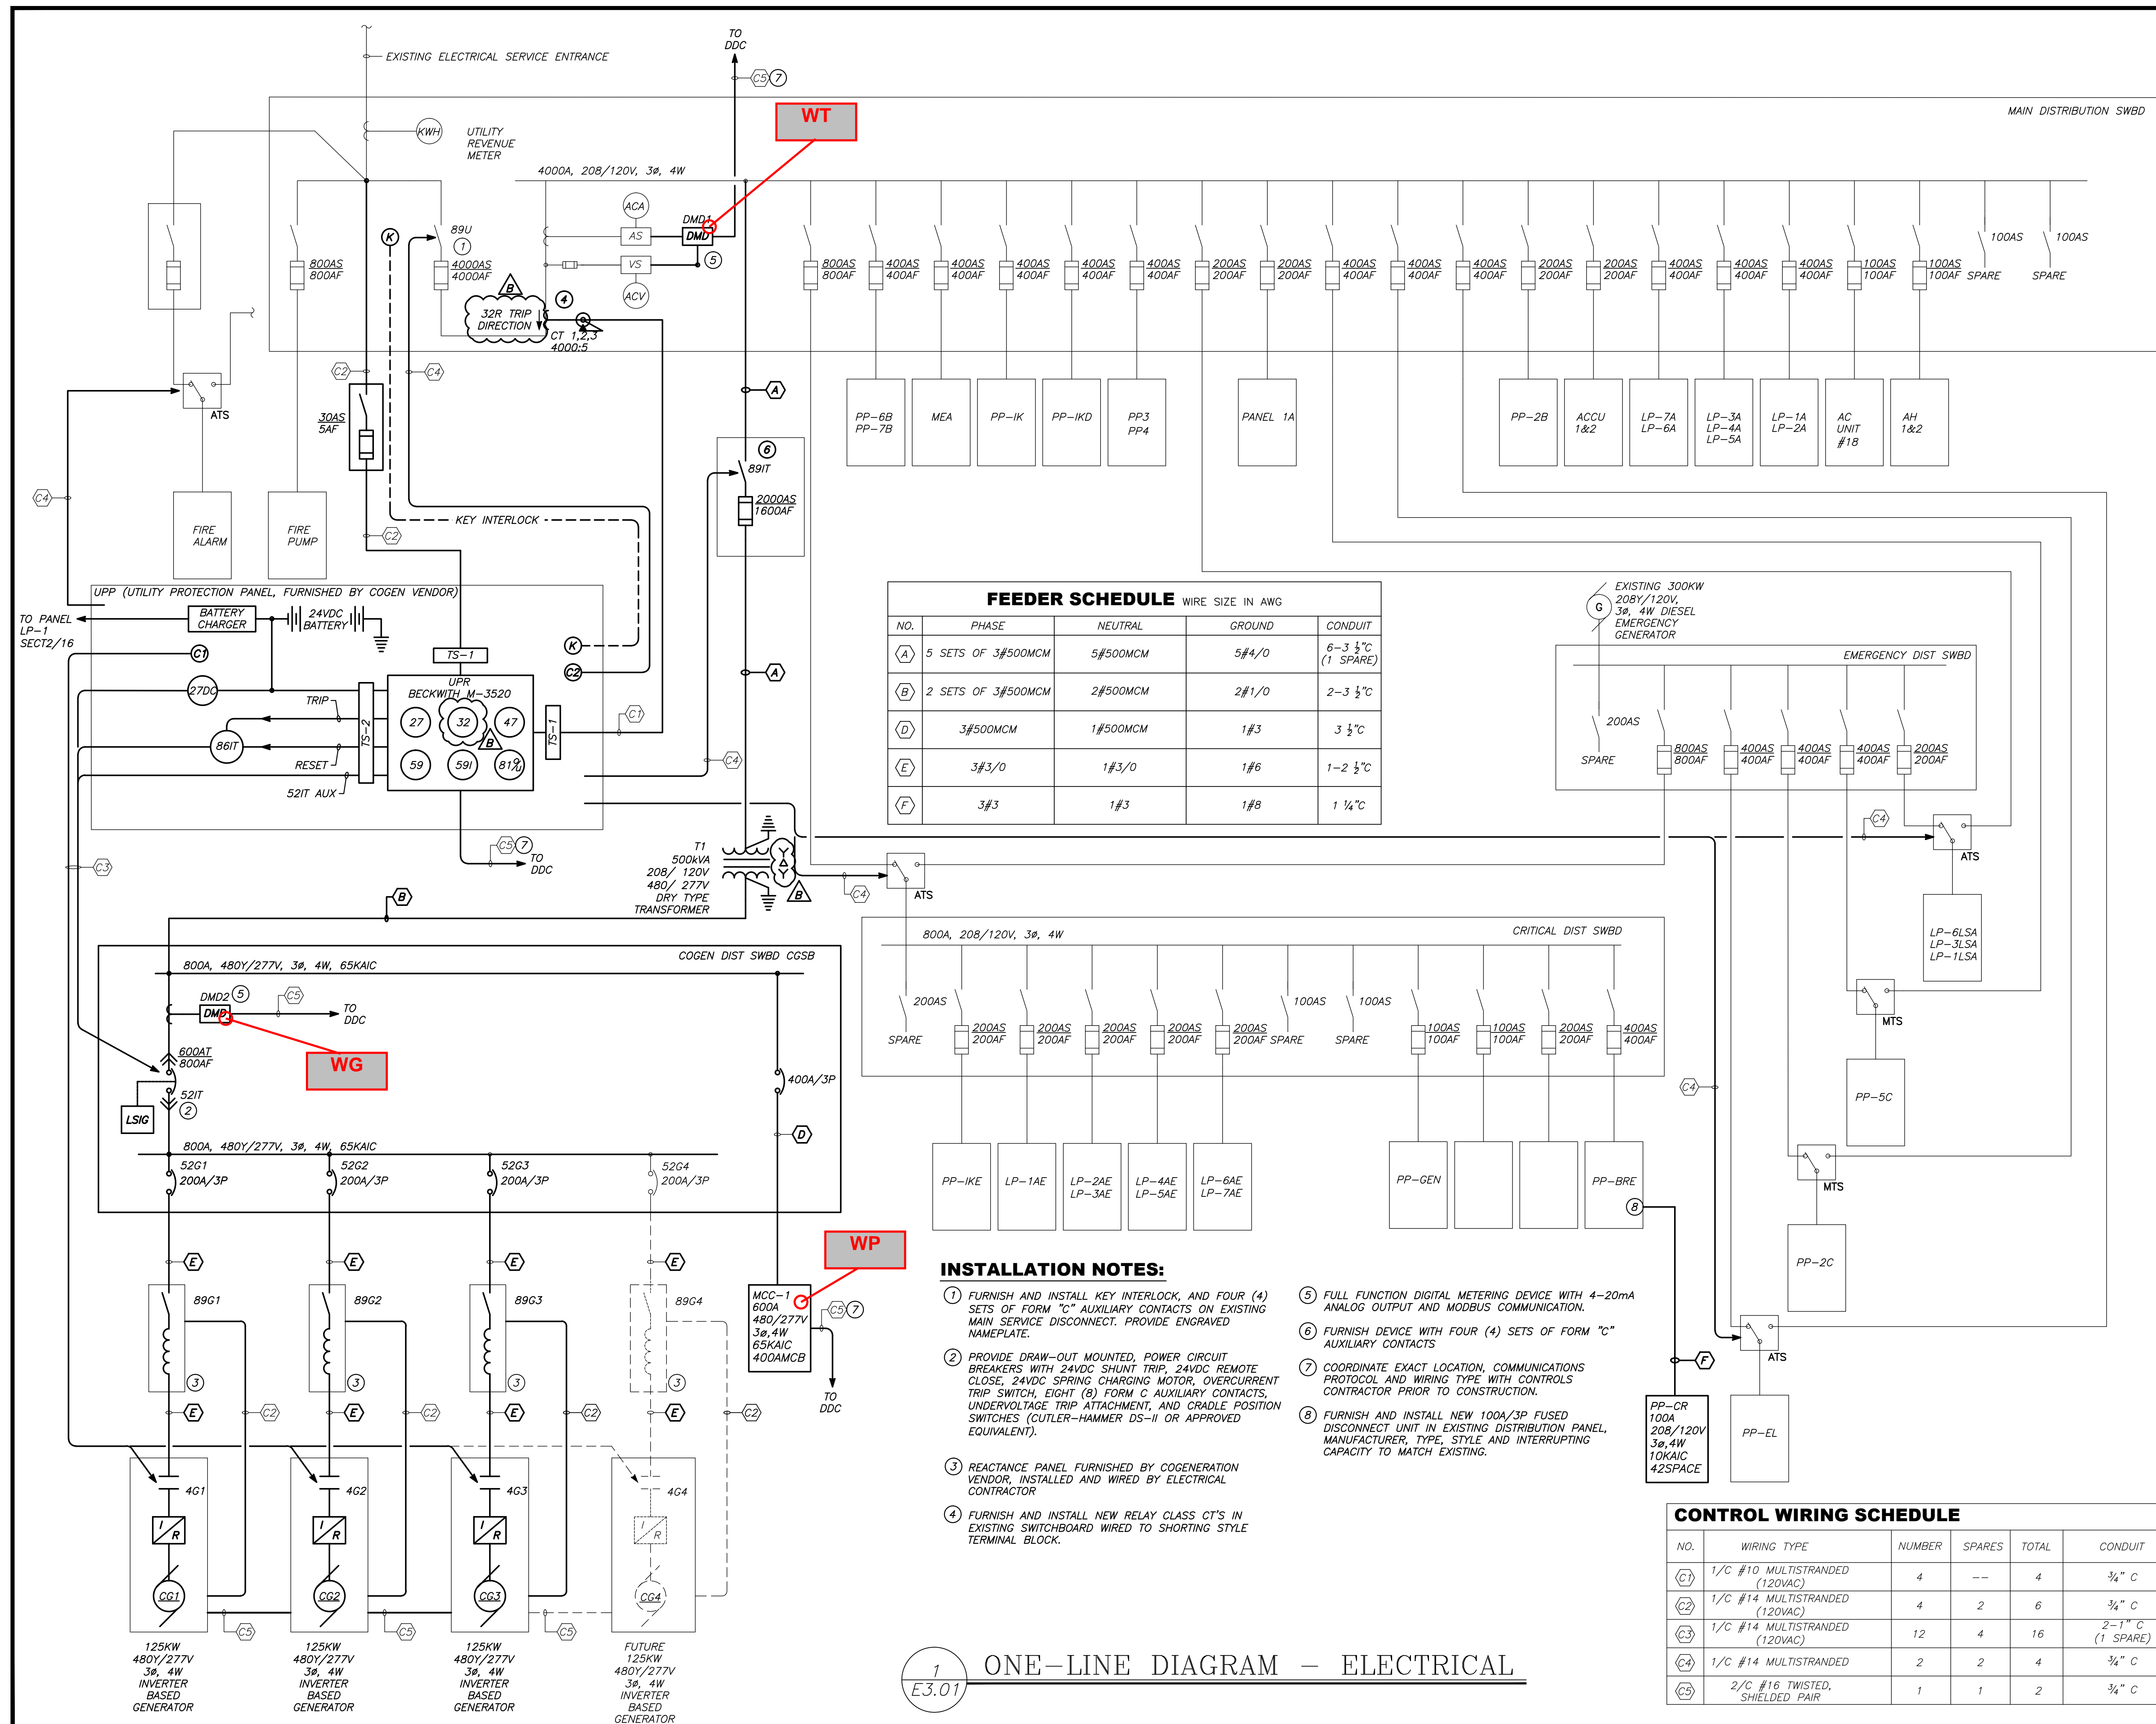

1 ONE-LINE DIAGRAM - ELECTRICAL
E3.01